


NOTE: THE DESIGN and concept indicated by this print and accompanying documents are the sole property of craighead and associates, architects. they may not be used, copied, altered or reproduced in any form or manner, nor may they be assigned to any third party without written permission of the architects. prints not bearing the signed architects seal shall be schematic or design development drawing only, not for construction.

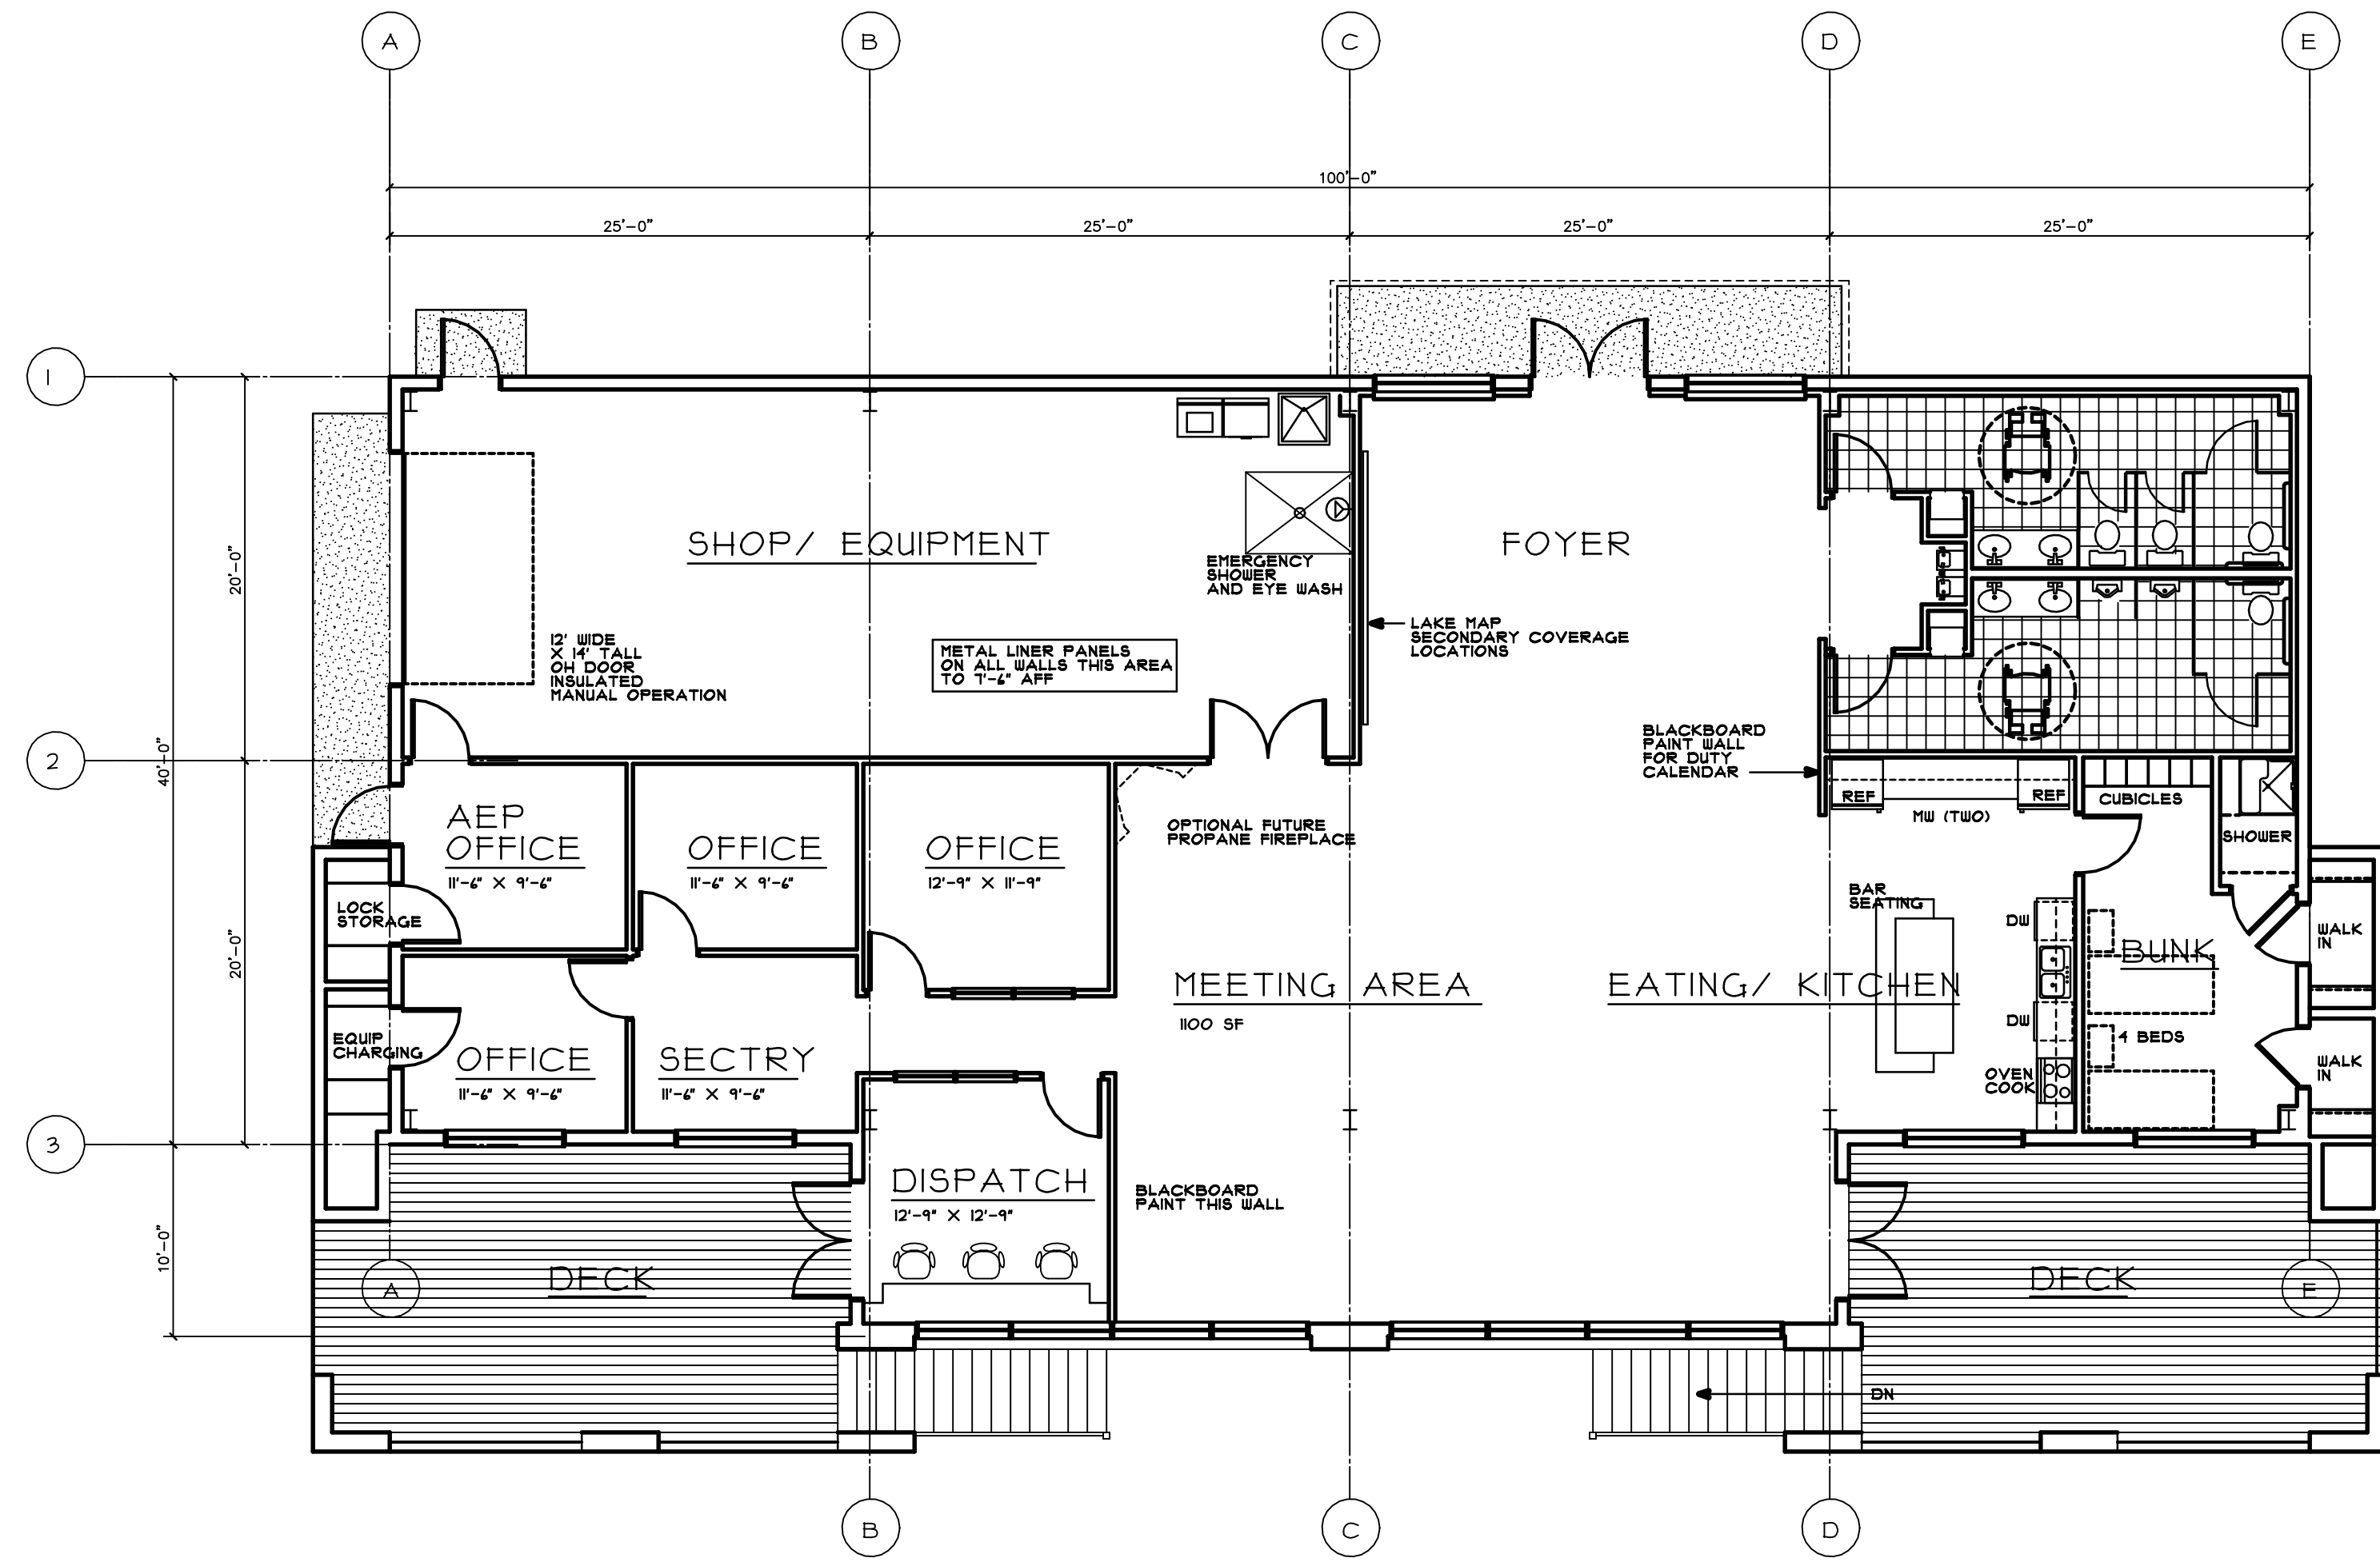

FLOOR PLAN

SCALE " 1/8" = 1'-0"

4500 SF

CRAIGHEAD ASSOCIATES
 Architects, Designers, Construction Managers
 3536 BRAMBLETON AVENUE SW
 SUITE 207
 ROANOKE, VIRGINIA 24018
 (540) 774-5326
 ccraigheadarchitect@yahoo.com

SCHEMATIC LAYOUT
 SMITH MOUNTAIN LAKE
 VOLUNTEER FIRE AND RESCUE
 SMITH MOUNTAIN LAKE MONETA, VA

REVISIONS	DATE
△ -----	---/---/---
△ -----	---/---/---
△ -----	---/---/---
△ -----	---/---/---
△ -----	---/---/---



SCHEMATIC LAYOUT
 SMITH MOUNTAIN LAKE
 VOLUNTEER FIRE AND RESCUE
 SMITH MOUNTAIN LAKE MONETA, VA

PROJECT NO: 2014032
 DATE: OCTOBER 10, 2011
 DRAWN BY: RLC
 CHECKED BY: RLC

APPROVED FOR THE OWNER _____ DATE _____

FLOOR PLANS

A-1

SCALE: 1/8" = 1'-0"
 GRAPHIC: